




WEST / DRIVE THRU ELEVATION



SOUTH / FRONT ELEVATION

NORTH / REAR ELEVATION

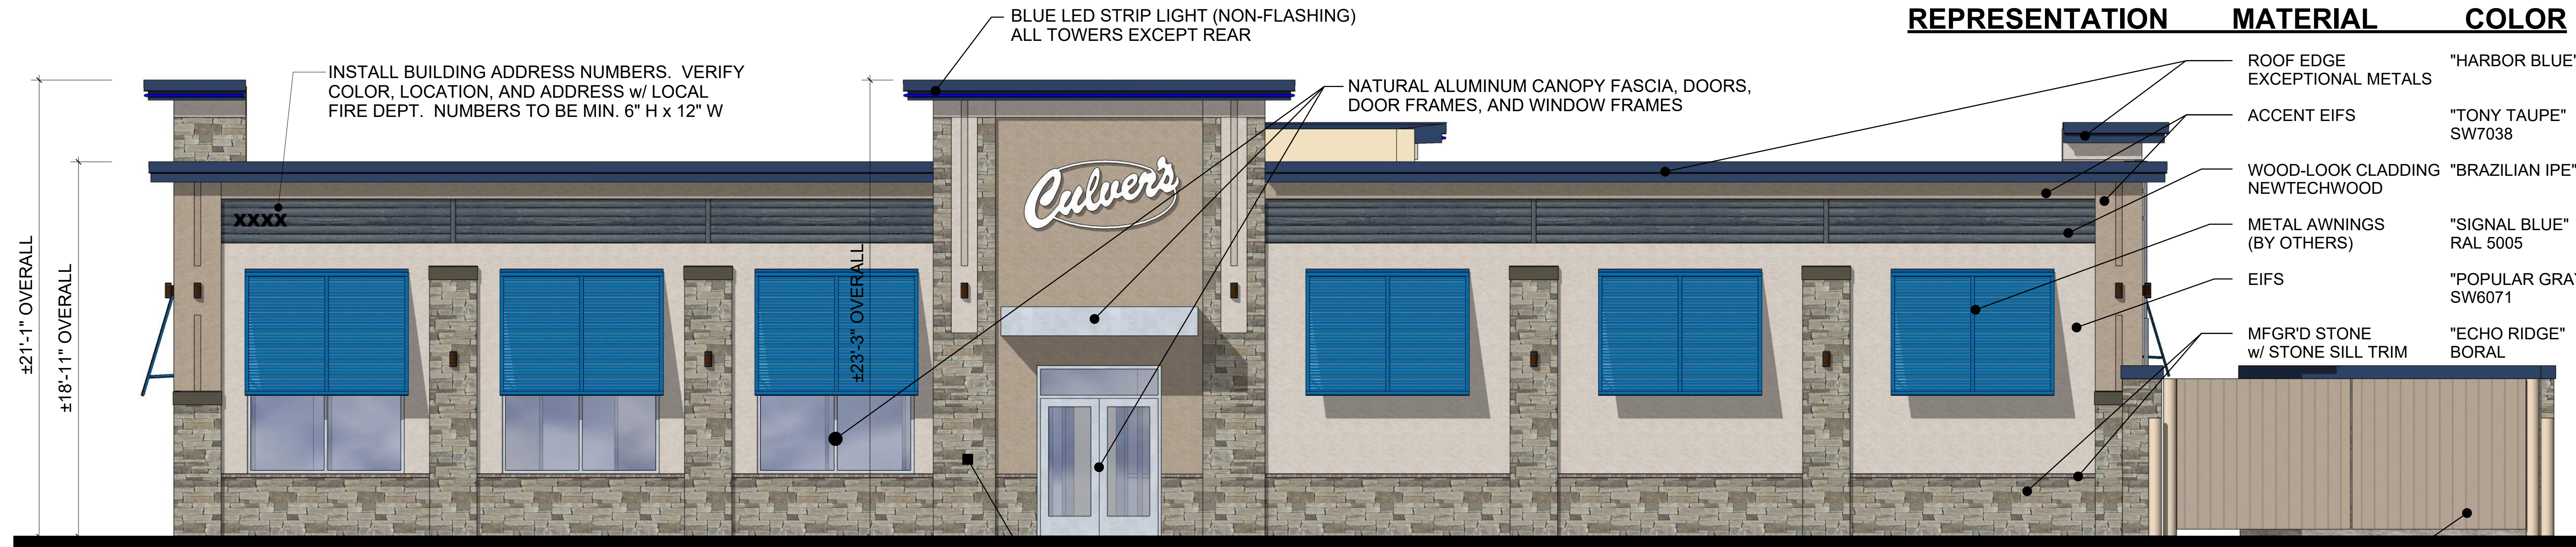


EAST / MAIN ENTRY ELEVATION


REPRESENTATION	MATERIAL	COLOR
ROOF EDGE	EXCEPTIONAL METALS	"HARBOR BLUE"
ACCENT EIFS		"TONY TAUPE" SW7038
WOOD-LOOK CLADDING	NEWTECHWOOD	"BRAZILIAN IPE"
METAL AWNINGS (BY OTHERS)		"SIGNAL BLUE" RAL 5005
EIFS		"POPULAR GRAY" SW6071
MFGR'D STONE w/ STONE SILL TRIM		"ECHO RIDGE" BORAL

©2023

NEW CULVER'S RESTAURANT
Highway 70 / NE Park Street
Okeechobee, FL 34973
County of Okeechobee

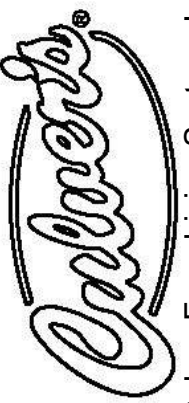
Culver Franchising System, Inc
1240 Water Street
Plainville, WI 53578
608-643-7980

OLLMANN ASSOCIATES
ARCHITECTS
200 South State Street
Belvidere Illinois 61008
815-544-7790 Phone

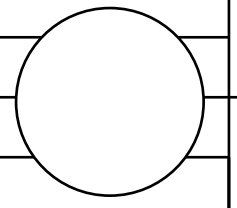

ELEVATIONS

NOTE: THOUGH THESE IMAGES HAVE PHOTO
REALISTIC QUALITIES, THE ACTUAL BUILDING
MATERIALS MAY VARY IN APPEARANCE.

Date: 01-26-2023 Revision:

2023-010

A1



REAR LEFT VIEW (NWC)



REAR RIGHT VIEW (NEC)



FRONT LEFT VIEW (SWC)




FRONT RIGHT VIEW (SEC)



LEFT PERSPECTIVE (WEST VIEW)



RIGHT PERSPECTIVE (EAST VIEW)

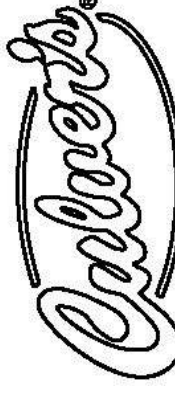©2023	
NEW CULVER'S RESTAURANT Highway 70 / NE Park Street Okeechobee, FL 34973 County of Okeechobee	
 Culver Franchising System, Inc 1240 Water Street Prairie du Sac, WI 53578 608-643-7980	
OLLMANN ASSOCIATES ARCHITECTS 200 South State Street Belvidere Illinois 61008 815-544-7790 Phone	
ELEVATIONS NOTE: THOUGH THESE IMAGES HAVE PHOTO REALISTIC QUALITIES, THE ACTUAL BUILDING MATERIALS MAY VARY IN APPEARANCE. Date: 01-26-2023 Revision:	
2023-010	
A2	

NOTE: SOME ITEMS INSTALLED BY OTHERS REQUIRE ROUGH-IN AND/OR WIRING BY CONTRACTOR AS NOTED IN PLUMBING AND ELECTRICAL SCHEDULES.

OWNER FURNISHED, FOOD SERVICE EQUIPMENT CONTRACTOR (FSEC) INSTALLED			
ITEM	EQUIPMENT SCHEDULE	ITEM	EQUIPMENT SCHEDULE
1	WALK-IN COOLER (BOX, LINE SETS, & COIL DRAIN PIPES)	44	GRILL SIDE WARMER CART
2	WALK-IN FREEZER (BOX, LINE SETS, & COIL DRAIN PIPES)	45	STAINLESS STEEL WALLCAP / ELEC CHASE COVER
3	WALK-IN COOLER RACKS	47	FRONT PASS-THRU STAINLESS STEEL CHANNEL TRIM
4	WALK-IN COOLER DUNNAGE RACKS	48	REFRIGERATED MEAT CART
4A	MOBILE CUSTARD MIX RACKS	50	MOBILE WORKTABLE
5	WALK-IN FREEZER SHELVING	51	GRILL AND STAND
6	WALK-IN FREEZER DUNNAGE RACKS	52	OPEN NUMBER
7	WORKTABLE / SINK	53	SANDWICH WRAP STATION
8	WALL SHELF	54	ORDER BARS
11	LOCKERS	57	STAINLESS STEEL REFRIGERATION CHASE COVER
14	STAINLESS STEEL WALL CORNER GUARDS, SHOWN 14	58	FRY STATION HEAT LAMP
16	OPEN NUMBER	60	FRYERS
20	DISHTABLES AND UTENSIL SINKS	61	CUSTOM FISH REFRIGERATOR
21	WALL SHELF	62	OPEN NUMBER
24	OPEN NUMBER	65	MOBILE STAINLESS STEEL WORKTABLE
27	SLANTING WALL SHELF	66	FUTURE ICE MACHINE - ROUGH-IN ONLY
29	CLEAN PAN SHELVING	66A	REMOTE ICE MAKER
31	JANTOYS SHELVING	67	OPEN NUMBER
34	REACH-IN FREEZER	68	WALL SHELF
35	NOT USED	71	WORK TABLE
37	REFRIGERATED DRAWER BASE	74	REFRIGERATED TOPPING TABLE
38	OPEN NUMBER	75	CUSTARD DIPPING CABINET
39	OPEN NUMBER	76	CAKE CONE DISPENSER
40	BREAD SHELF - NOT INCLUDED	77	SUNDAE TOPPING SYSTEM
41	REFRIGERATED WORKTABLE	78	DISH / CUP DISPENSERS
42	MOBILE WORKTABLE / OVERSHELF	79	WALL SHELVES

OWNER FURNISHED, VENDOR INSTALLED			
ITEM	EQUIPMENT SCHEDULE	ITEM	EQUIPMENT SCHEDULE
9	COOKER / WARMERS	98	ICED TEA BREWER / DISPENSER
12	WASTE OIL RECOVERY SYSTEM	99	DRIVE-THRU LID DISPENSER - NOT INCLUDED
15	BAG-IN-BOX SYSTEM	103	ICE AND SODA DISPENSER
17	TRASH CANS / CART	104	CARBONATOR
18	BUN RACKS	105	SELF SERVICE LID DISPENSER
33	CHEMICAL DISPENSING SYSTEM	111	STRAW DISPENSERS
36	MICROWAVE OVEN	112	CONDIMENT PANS
43	BUN TOASTER	118	MONITOR BRACKETS
46	OPEN NUMBER		
55	WRAP PAPER HOLDERS		
56	HEATED BUN WARMER		
63	TRIPLE CUSTARD MACHINE		
69	ASTRO BLENDERS		
70	MILKSHAKE MACHINE		
72	HEATED SYRUP DISPENSERS		
73	LIQUID TOPPING DISPENSERS		
84	COFFEE MAKER		
85	POWER WASHER - NOT INCLUDED		
86	MENU BOARD / SIGNAGE PACKAGE		
87	WAFFLE CONE DISPENSER		
88	OPEN NUMBER		
89	FOOD LABEL MARKER		
91	CASH REGISTER / POS SYSTEM		
96	ICE AND SODA DISPENSER		
97	CARBONATOR		

CONTRACTOR FURNISHED,
CONTRACTOR INSTALLED

ITEMEQUIPMENT SCHEDULE

25ADISHWASHER CONDENSATE HOOD - NOT INCLUDED


28FIRE SUPPRESSION SYSTEMS

32MOP SINK

49EXHAUST HOOD - GRIDDLE

59EXHAUST HOOD - FRYERS


OWNER FURNISHED, CONTRACTOR INSTALLED	
ITEM	EQUIPMENT SCHEDULE
10	KETCHUP VOL PAK DISPENSER
13	WASHER / DRYER
19	HAND SINK
22	PRE-RINSE SPRAY ASSEMBLY
23	PRE-RINSE SPRAY ASSEMBLY
25	DISHWASHER
26	BOOSTER HEATER
30	EYE WASH STATION (CONTRACTOR TO PROVIDE MIXING VALVE PER PLUMBING SCHEDULE)
64	WATER FILTER
116	HAND TOWEL DISPENSERS
117	TOILET PAPER DISPENSERS
300	TRIM PACKAGE (SEE H2 / A103)
	FOOD SERVICE EQUIP. COUNTER BASES (SEE FINISH PLAN)
	SHARPS CONTAINERS
	AED OPTIONAL - CONFIRM WITH OWNER
	MOP HANGER
	ARTWORK (SEE SHEET A103.1)

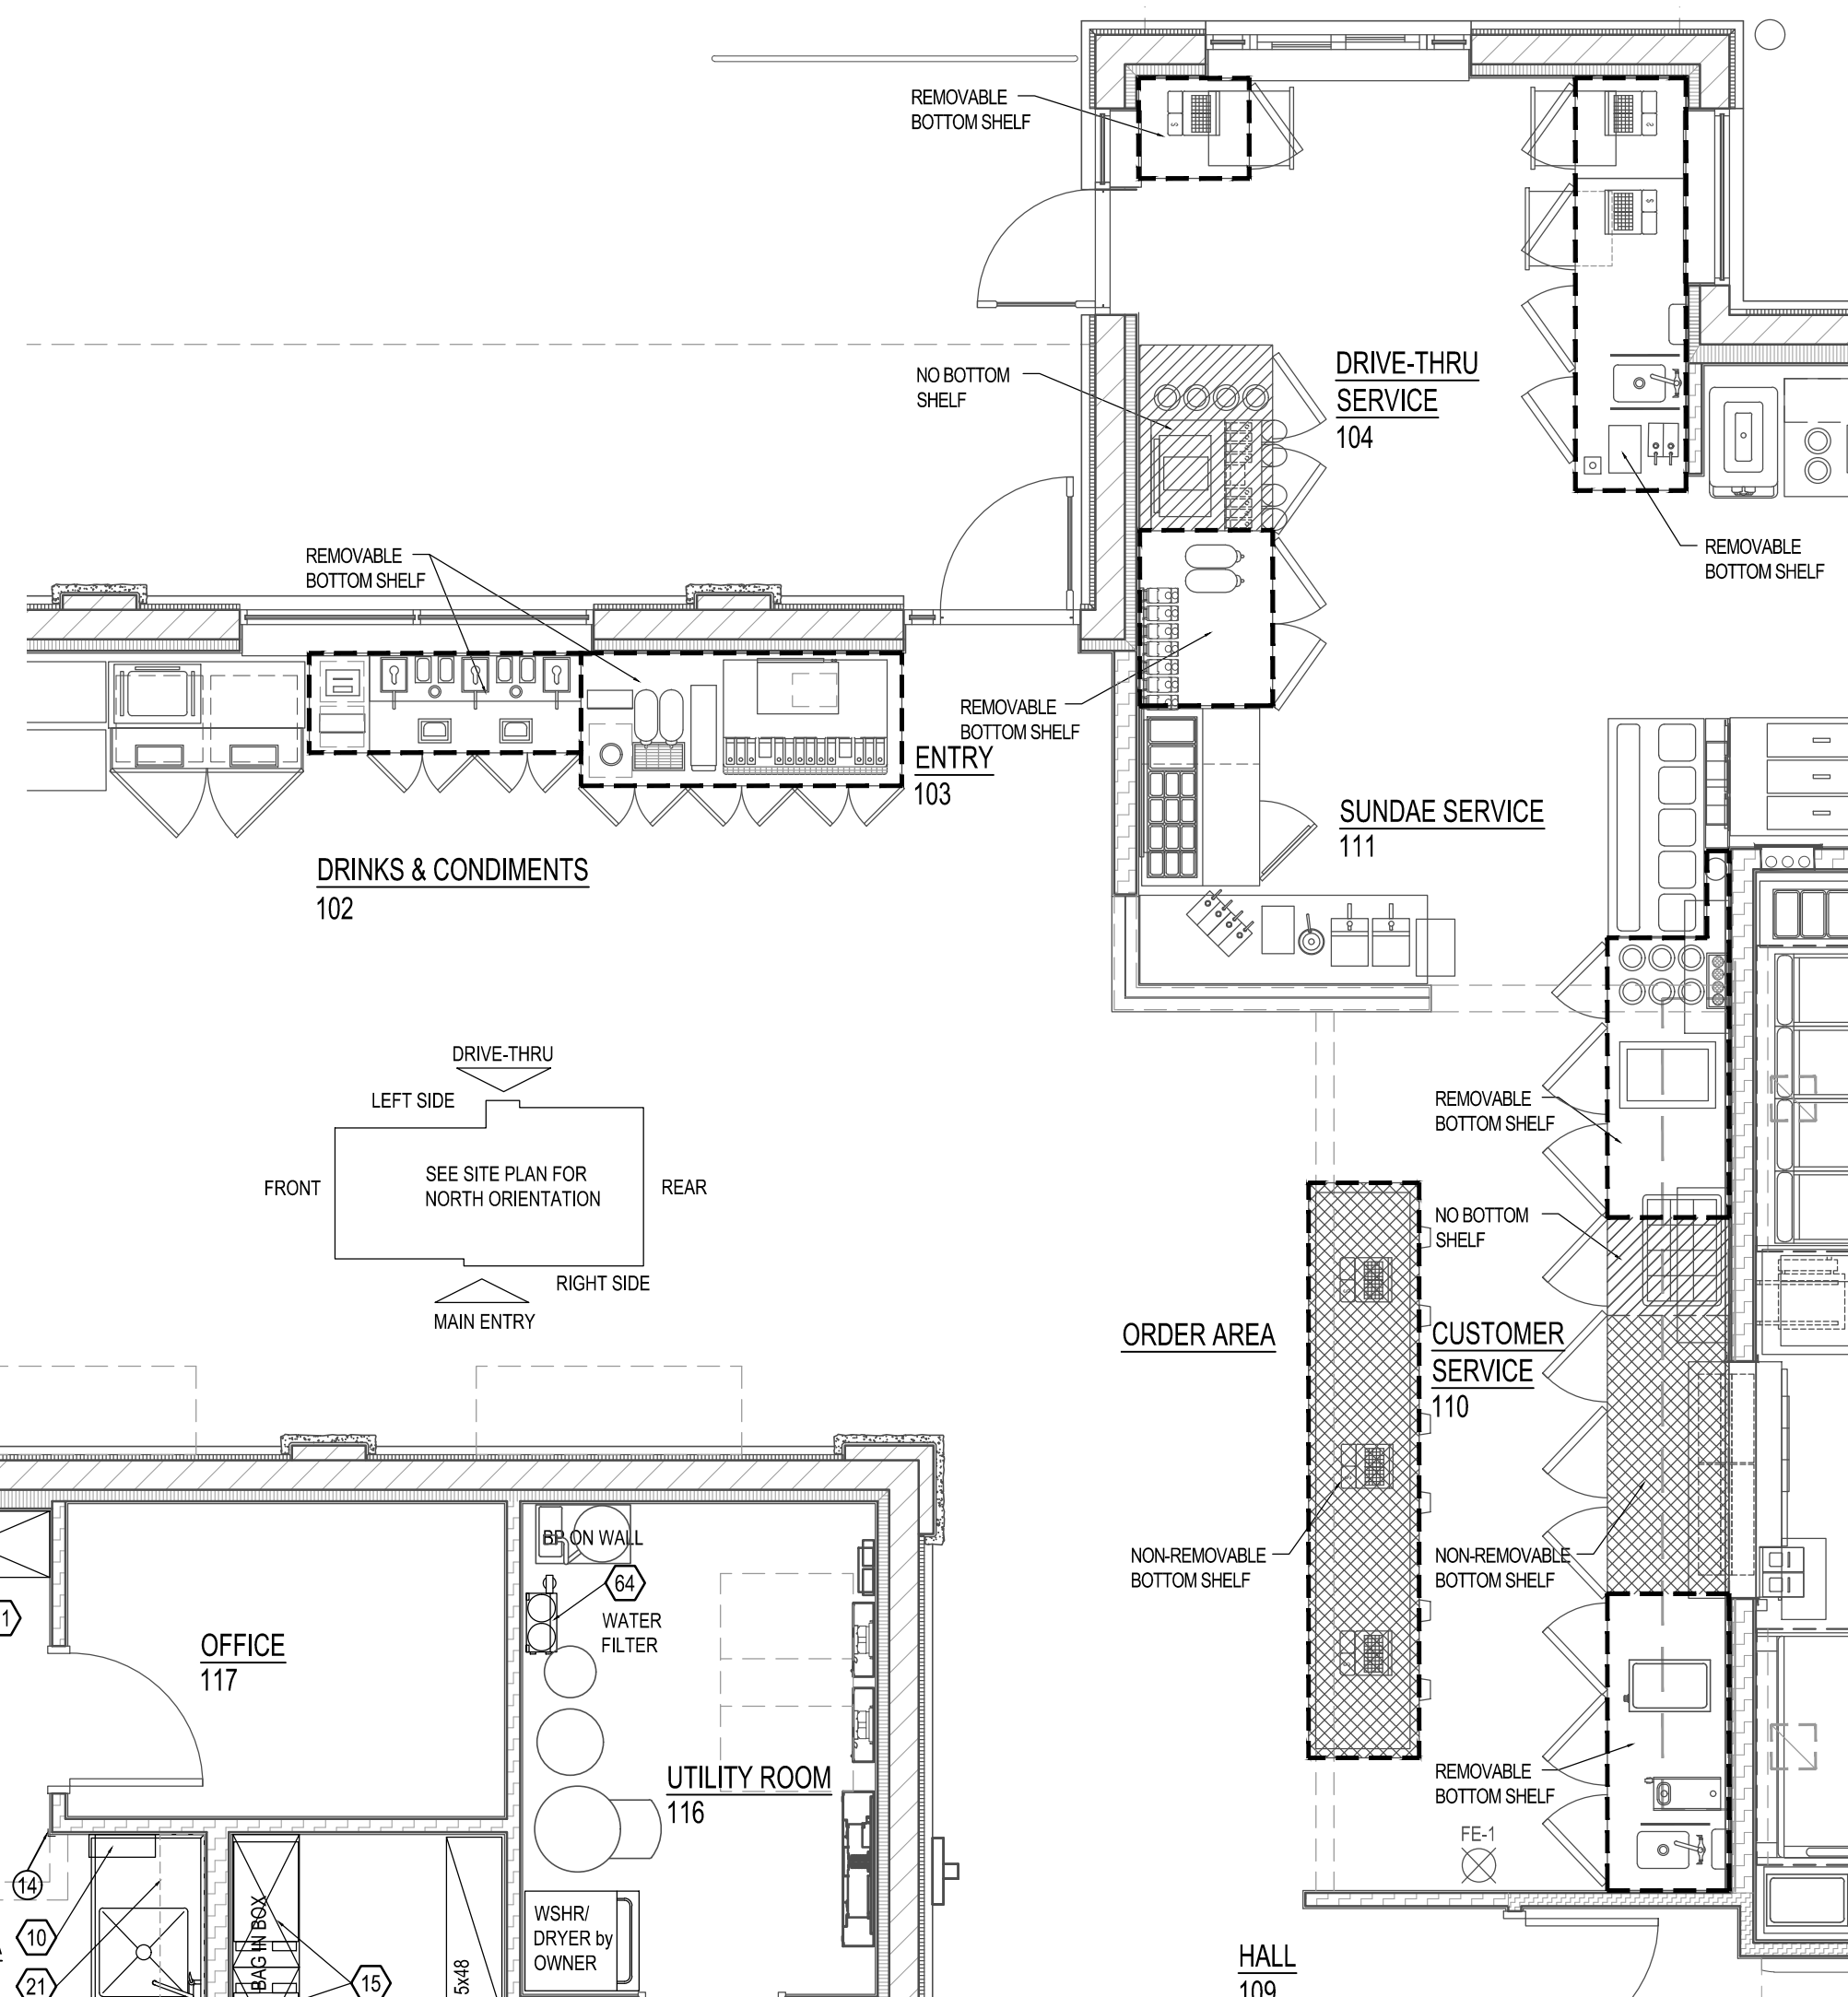

C3 CABINET BASE DETAIL
SCALE: 1/4" = 1'-0"

SEATING SUMMARY	
2	5-TO-GO / ORDER WAITING
12	4-PERSON TABLES = 48 SEATS
1	3-PERSON TABLES = 9 SEATS
18	2-PERSON TABLES = 36 SEATS
33	TOPS
99	SEATS

FOODSERVICE PLAN
SCALE: 1/4" = 1'-0"

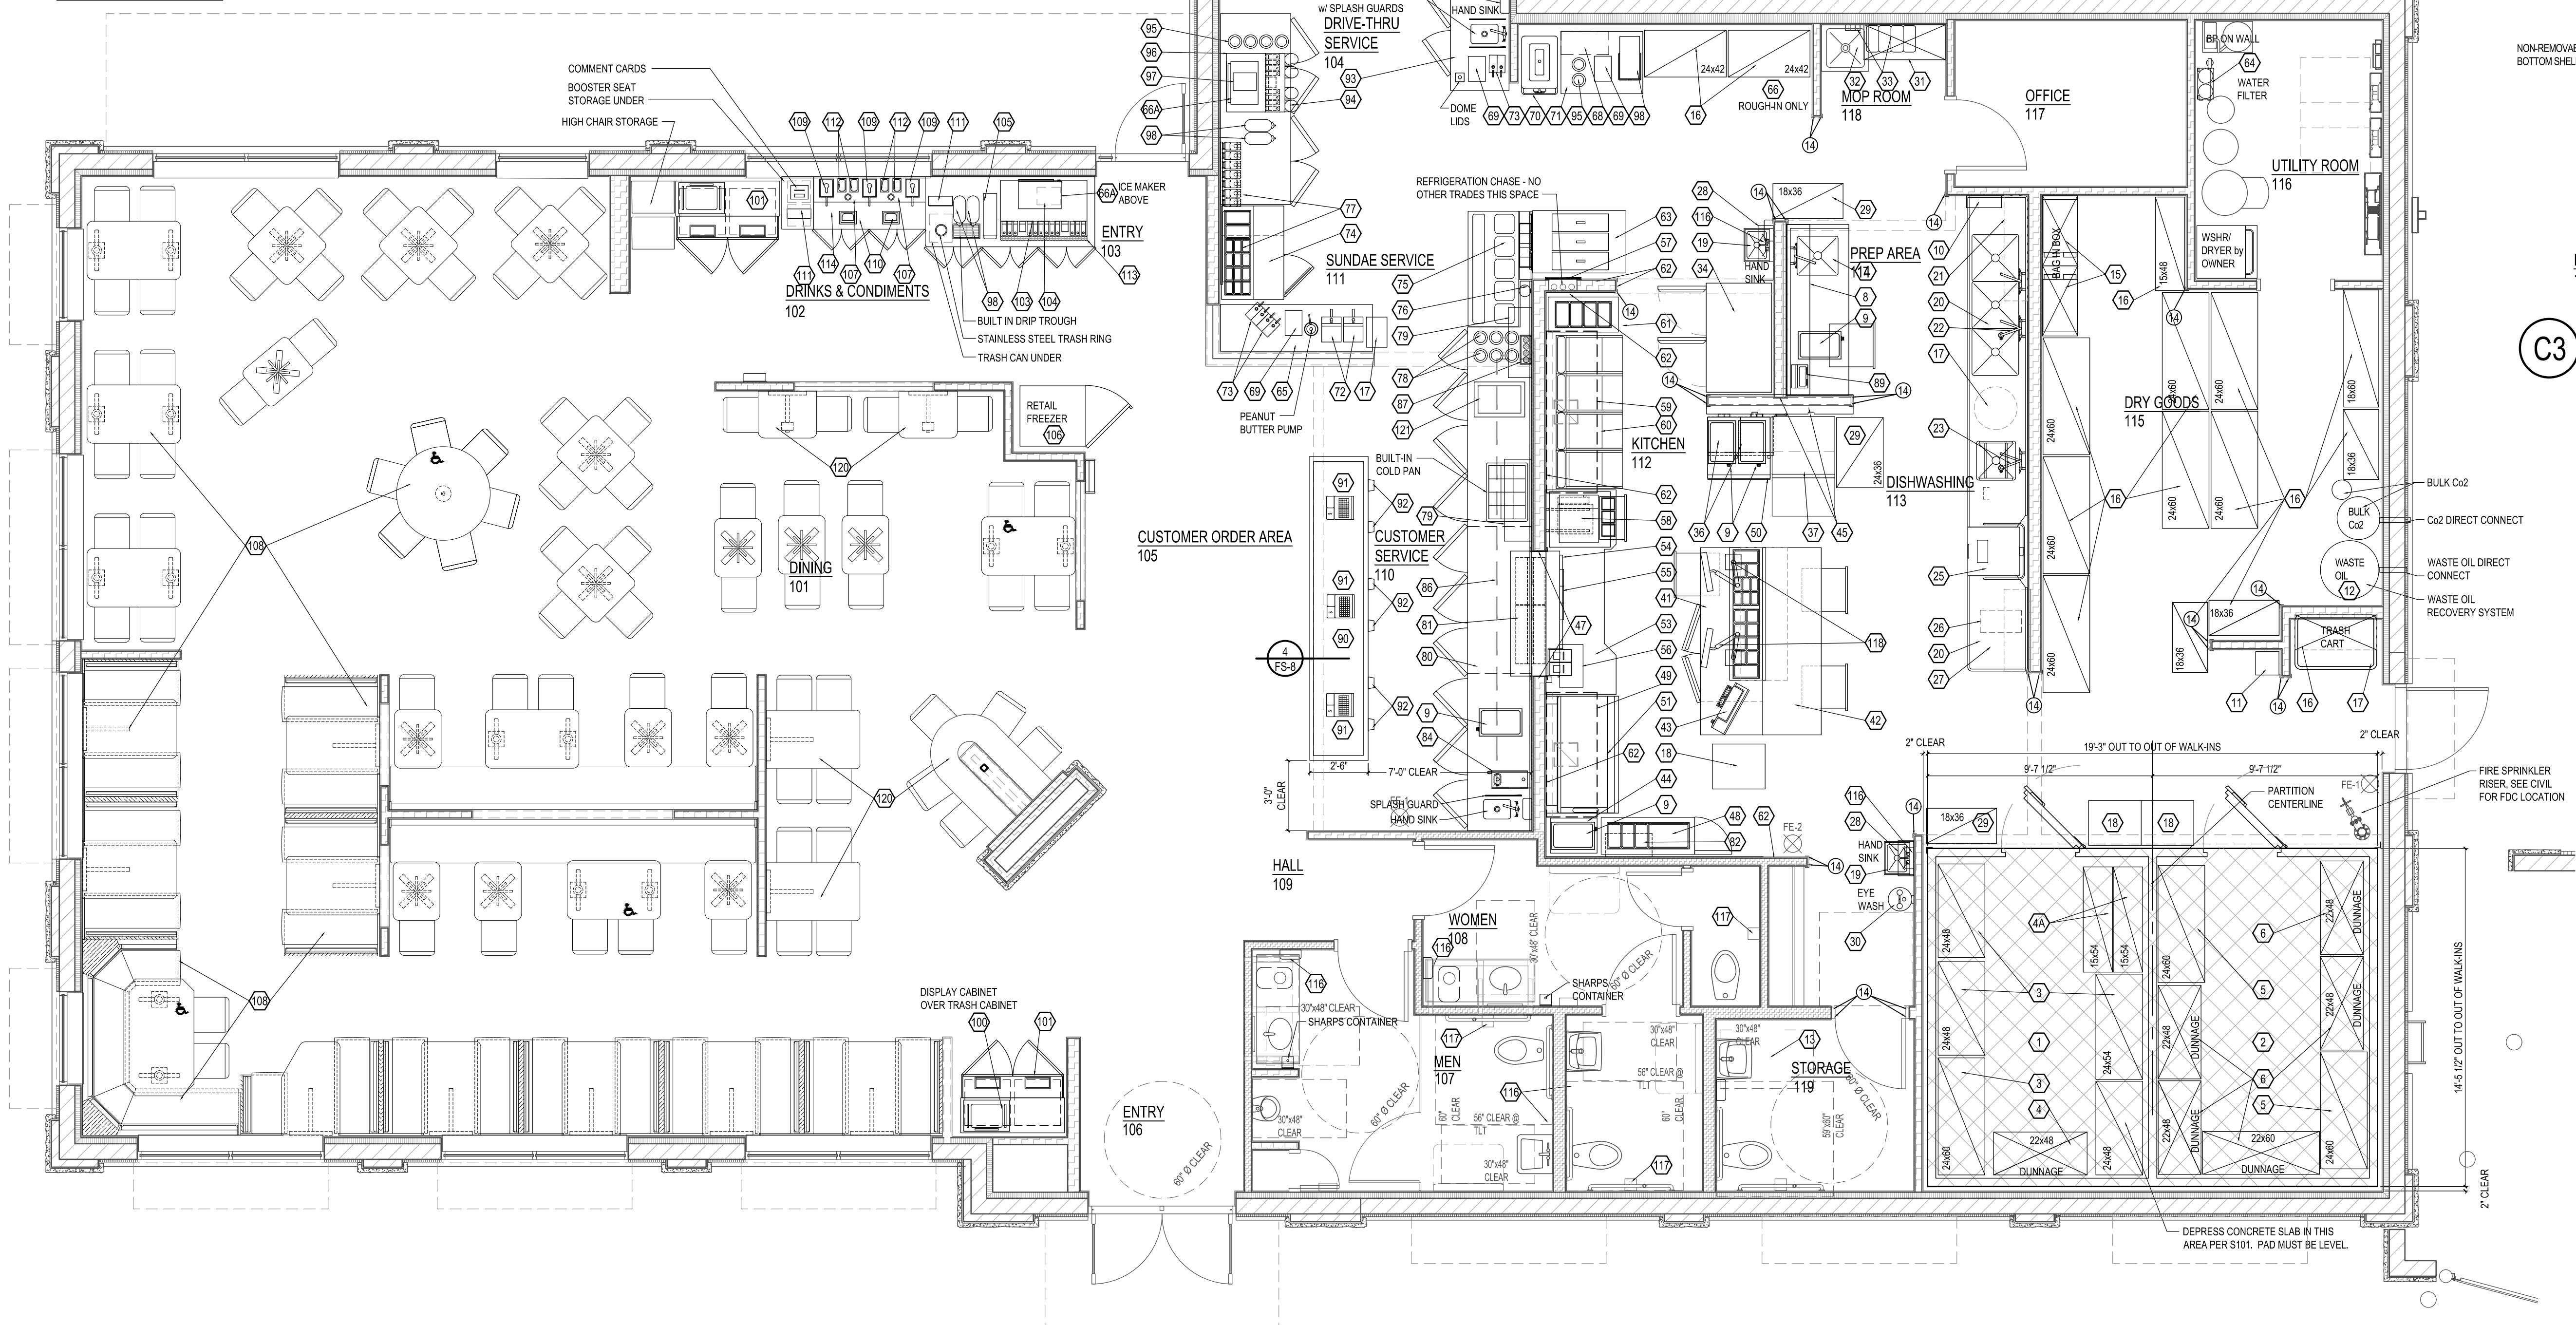

© 2023

NEW CULVER'S RESTAURANT
975 NE Park Street
Okeechobee, FL 34973
County of OKEECHOBEE

SEAL

OWNER:
S & L Properties Okeechobee LLC
2651 Kyrking Court
Portage, WI 53901
Jeffrey J. Liegel, Realty Manager / Member
608-742-2893


OLLMANN ASSOCIATES ARCHITECTS, P.C.
200 South State Street
Belvidere, Illinois 61008
815-544-7790 Phone
© OAA. All rights reserved. Any copying, transmittal or
disclosure subject to OAA written approval.

FOOD SERVICE PLAN

Revision:
Date: 1-27-2023


2023-010

FS-1

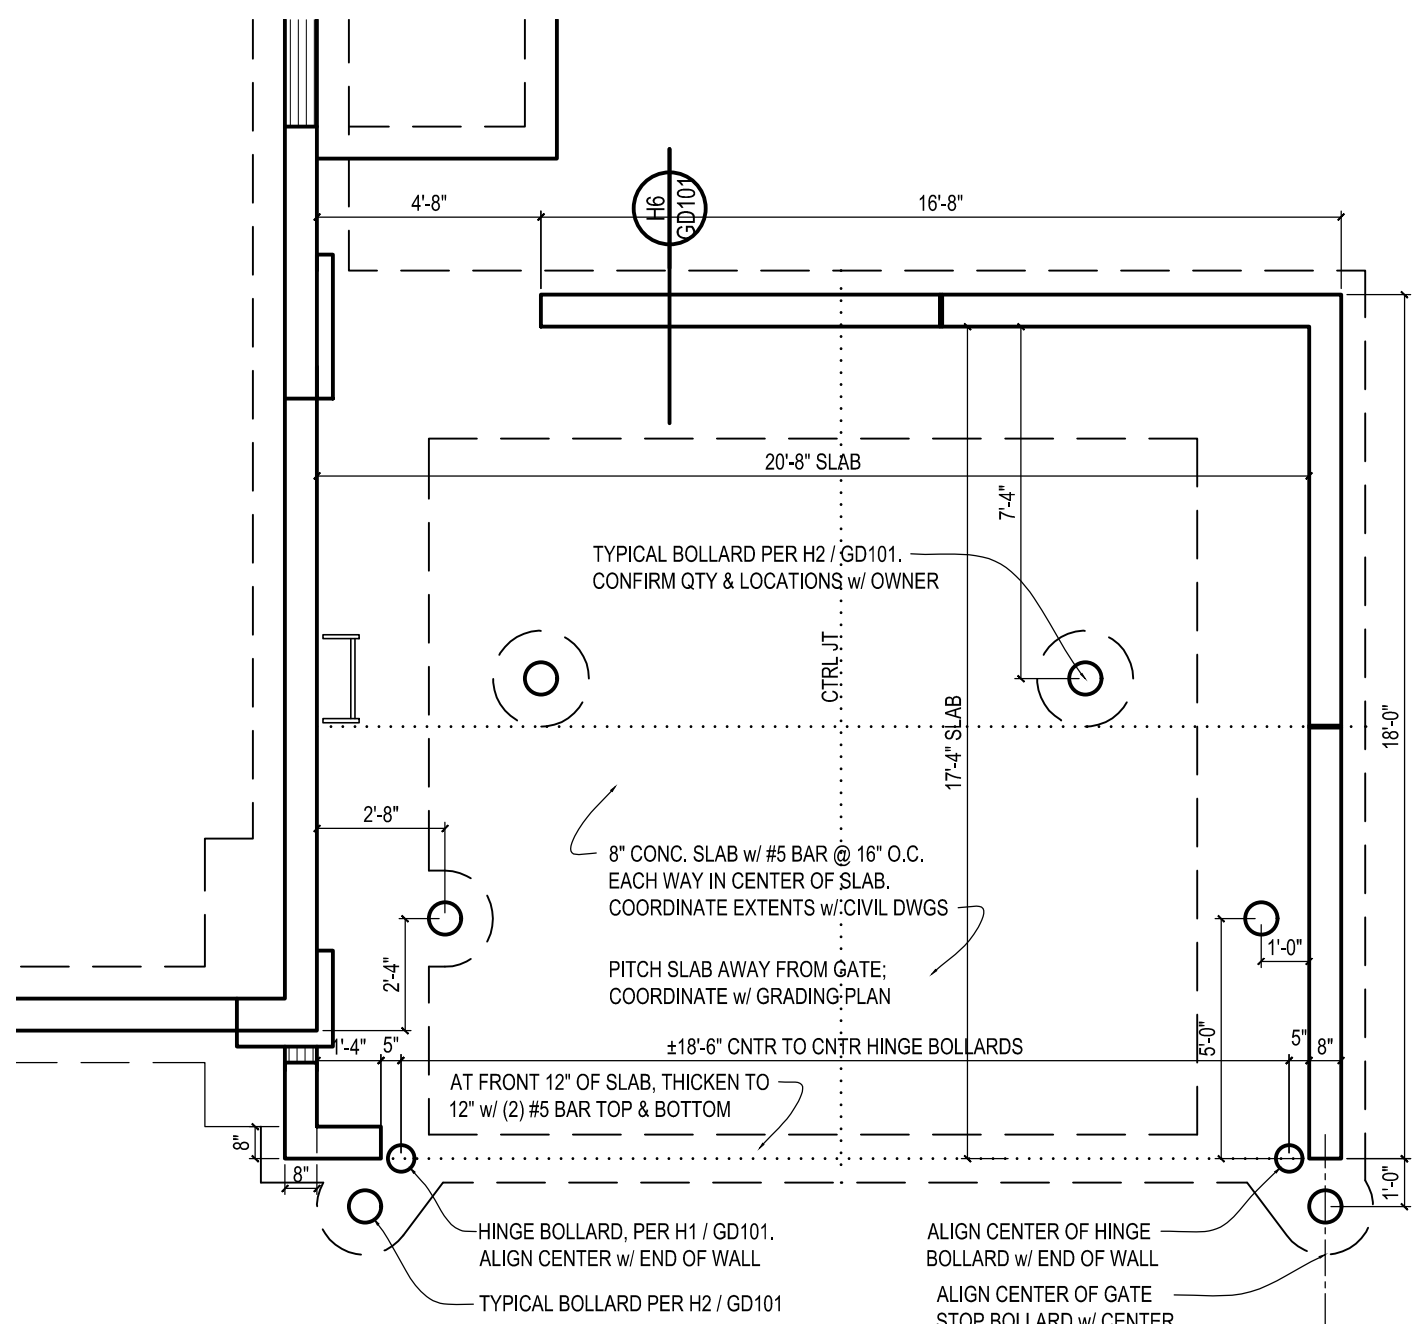


SEE CIVIL DRAWINGS FOR LOCATION OF ENCLOSURE


C2 FOUNDATION PLAN
SCALE : 1/4" = 1'-0"

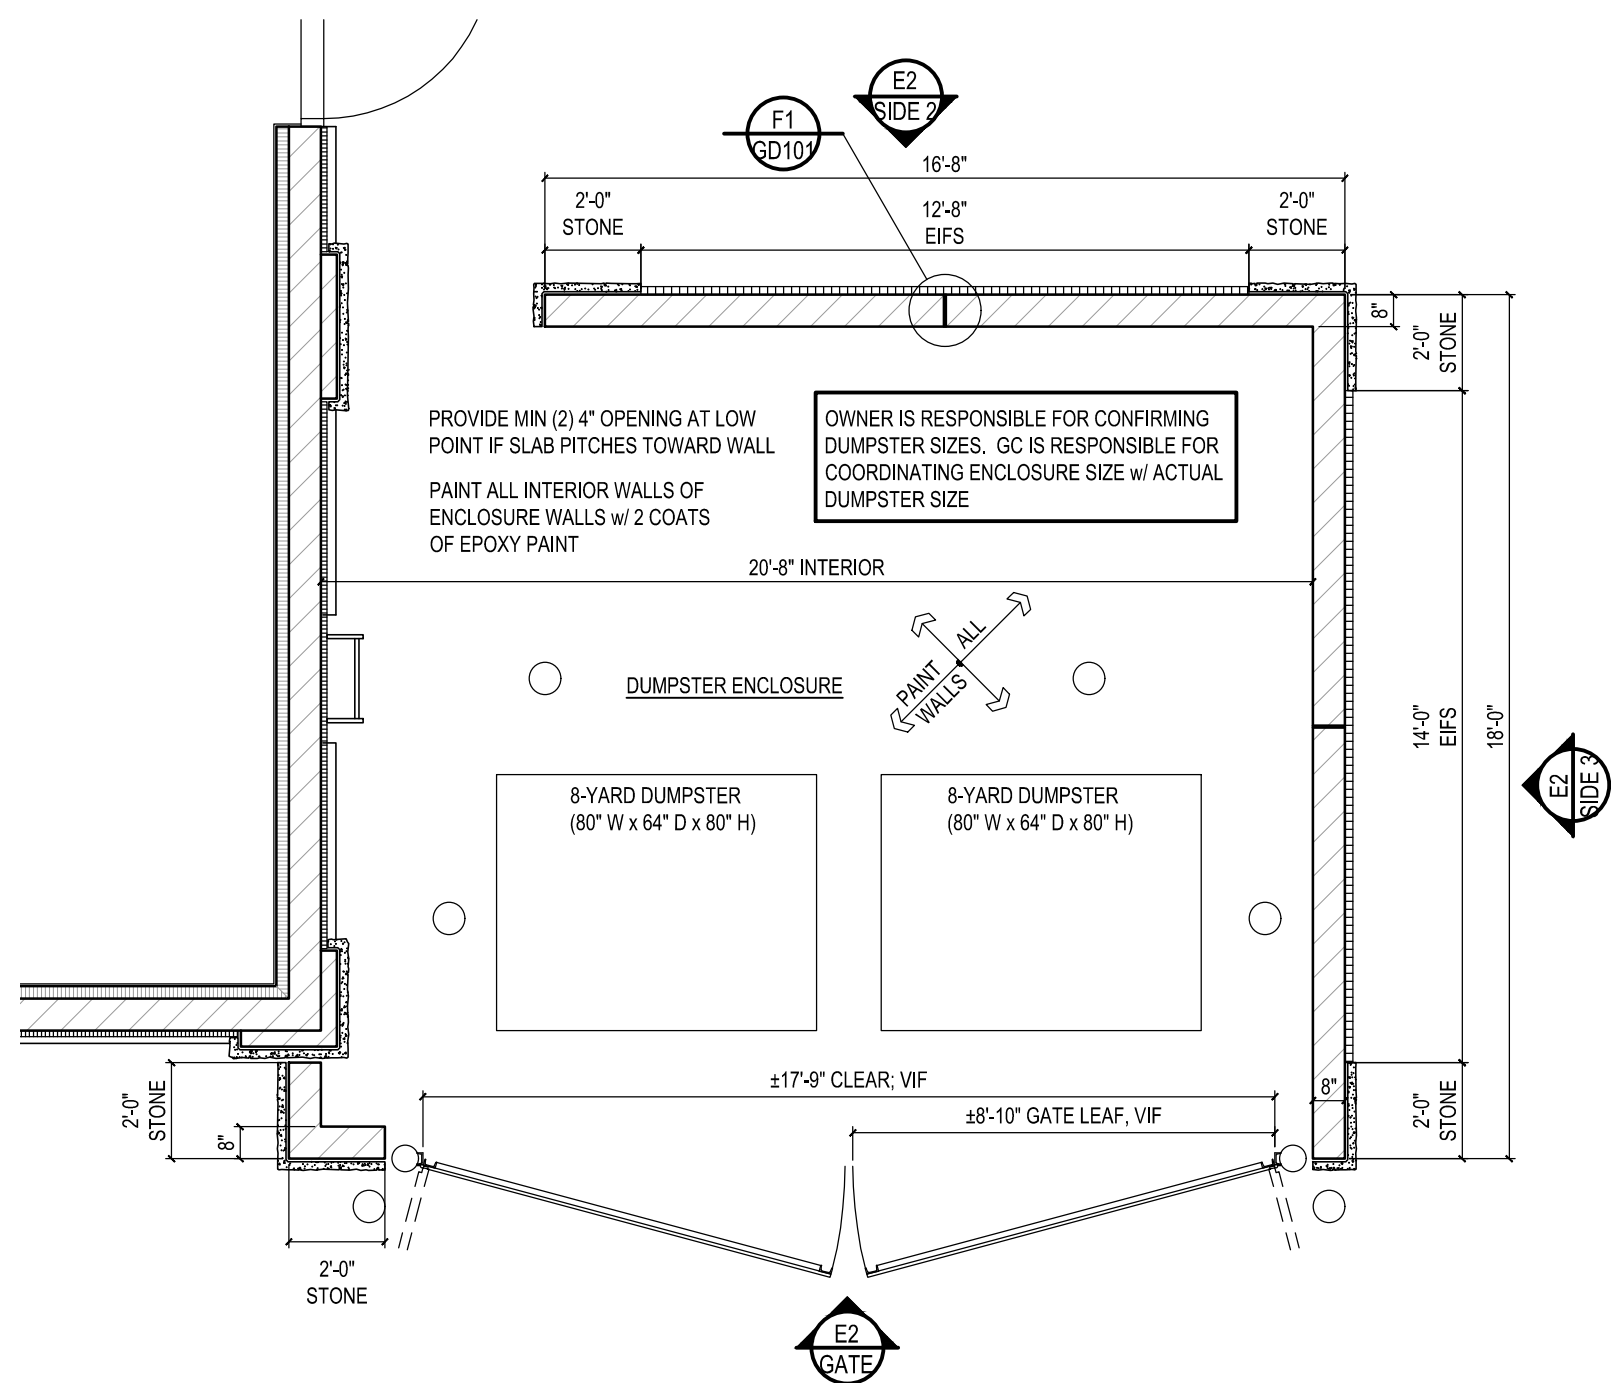


C3 FLOOR PLAN
SCALE : 1/4" = 1'-0"

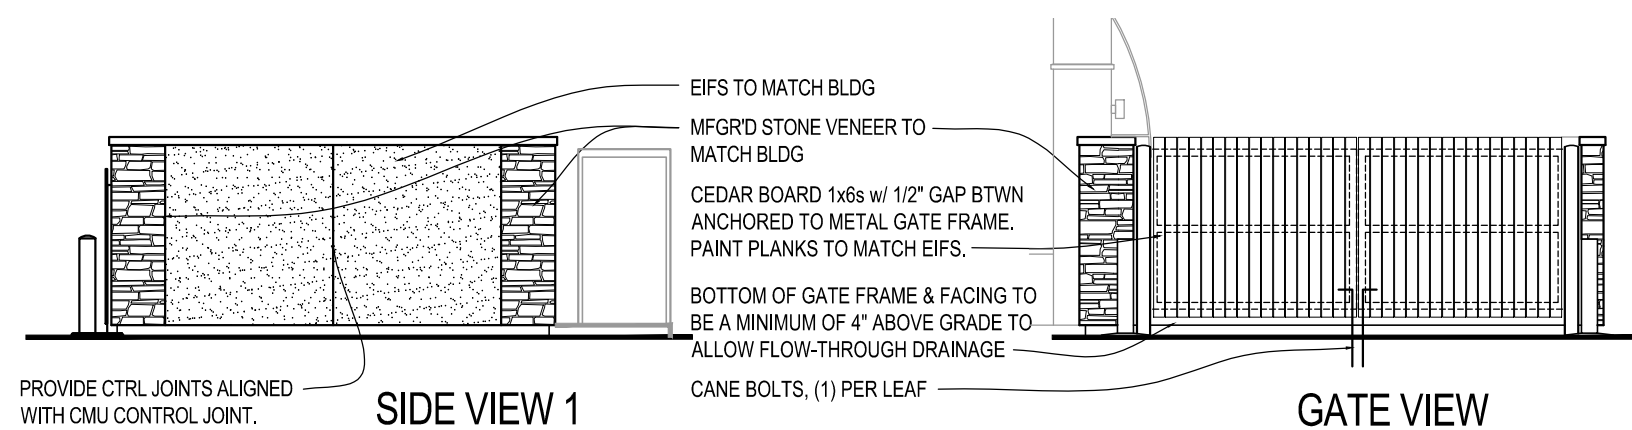


E2 ENCLOSURE ELEVATIONS
SCALE : 1/8" = 1'-0"

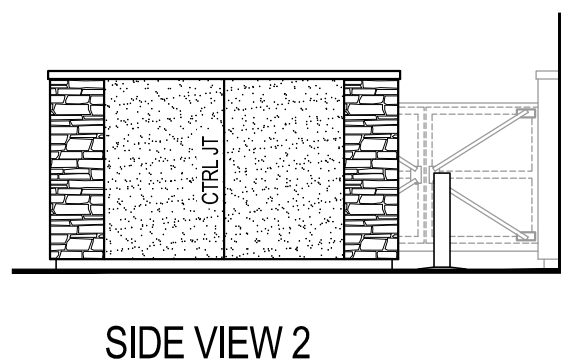


SIDE VIEW 2

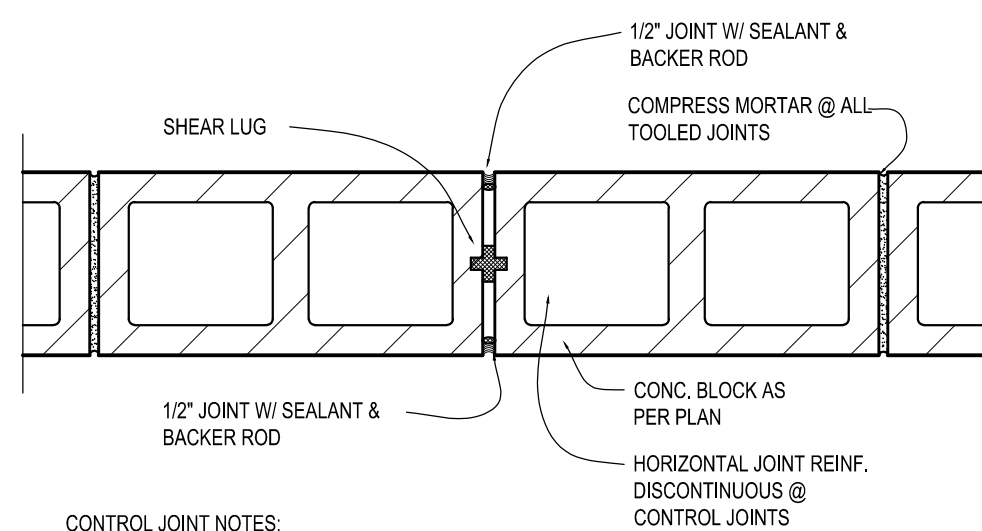


F1 CMU CONTROL JOINT
SCALE : 1 1/2" = 1'-0"

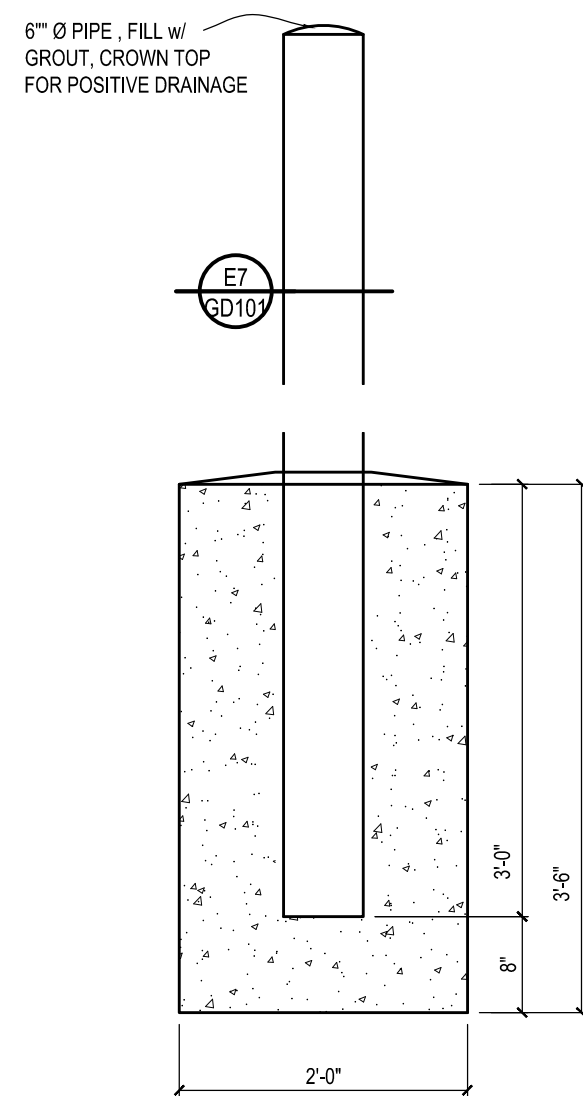


H1 HINGE BOLLARD
SCALE : 3/4" = 1'-0"

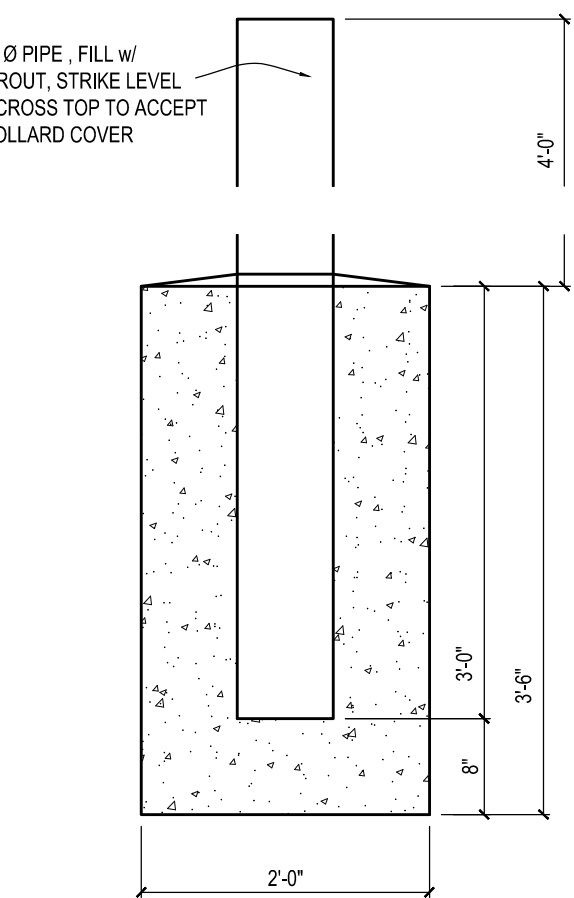


H2 BOLLARD
SCALE : 3/4" = 1'-0"

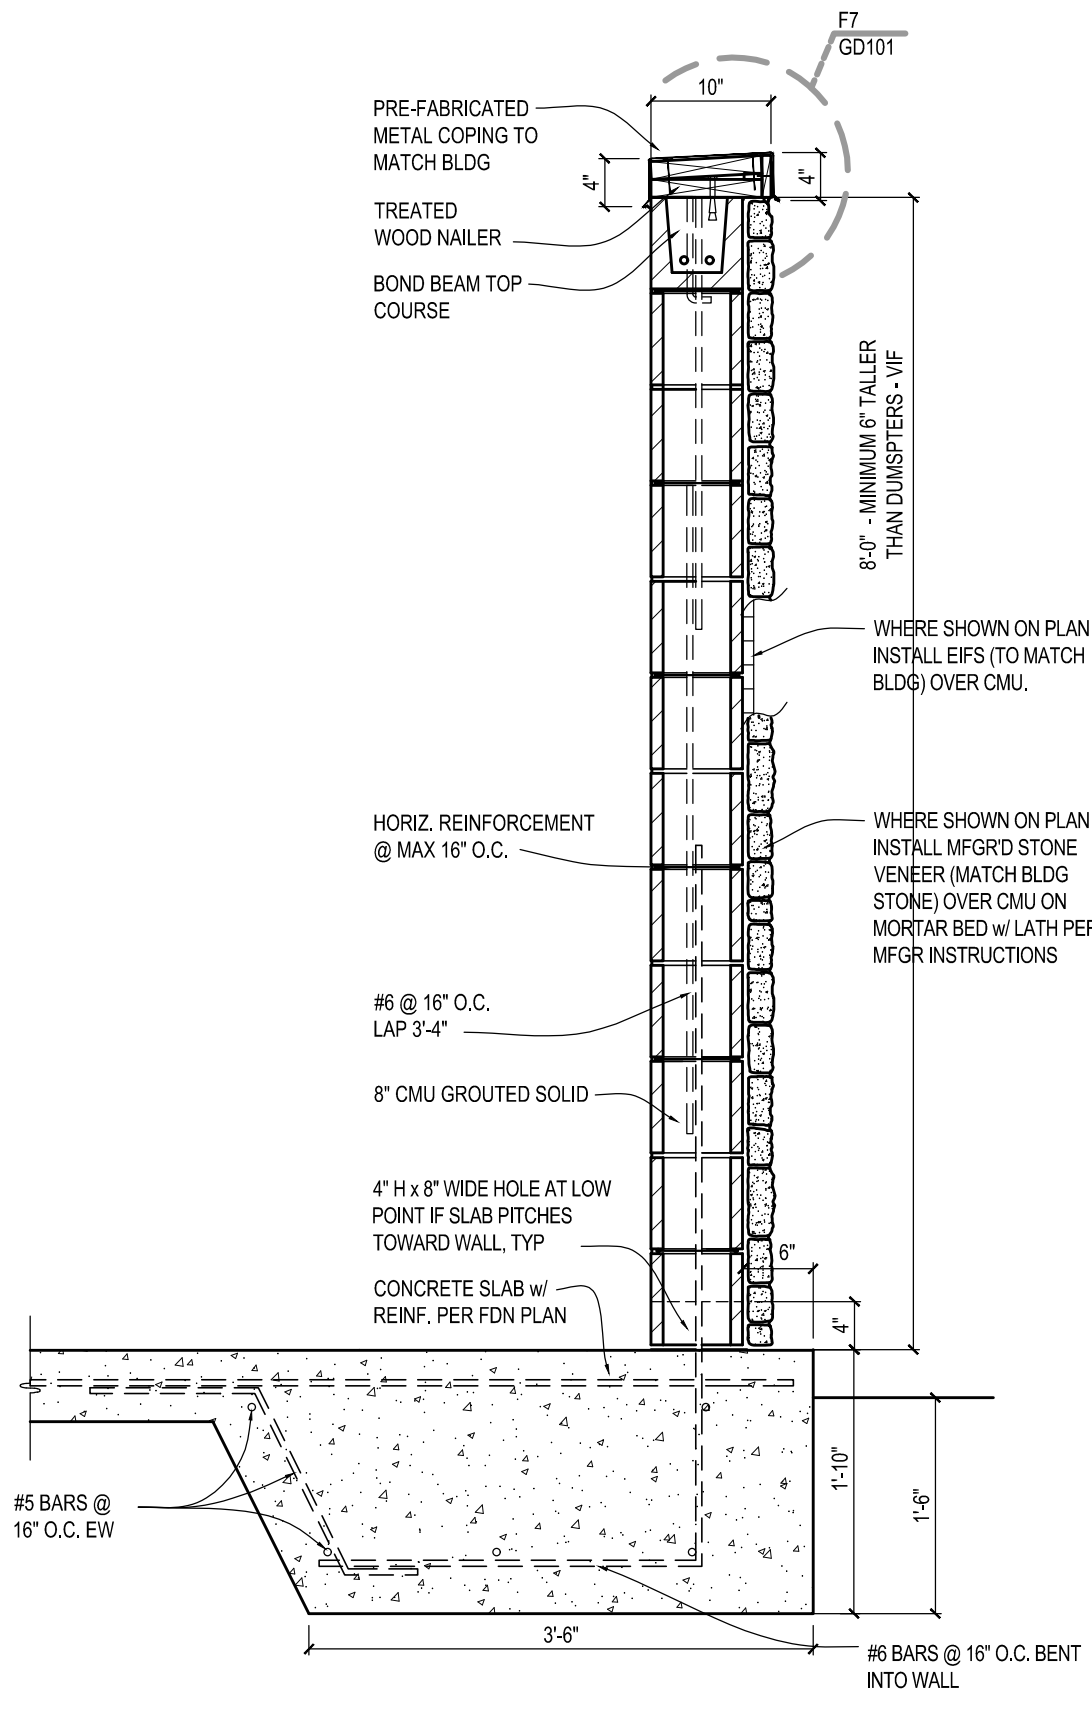


H6 ENCLOSURE WALL
SCALE : 3/4" = 1'-0"

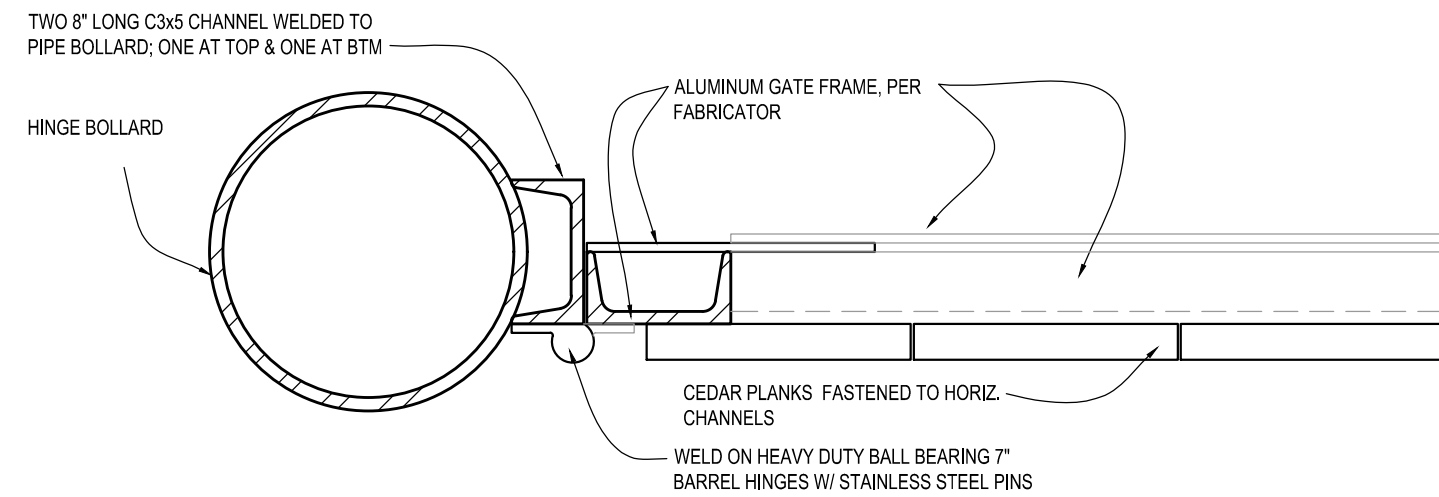


E7 HINGE DETAIL
SCALE : 3" = 1'-0"

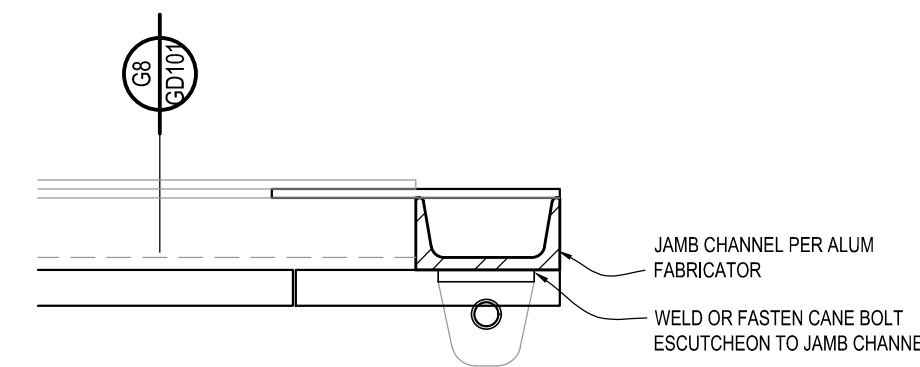


E8 SECT @ GATE MTG STILES
SCALE : 3" = 1'-0"

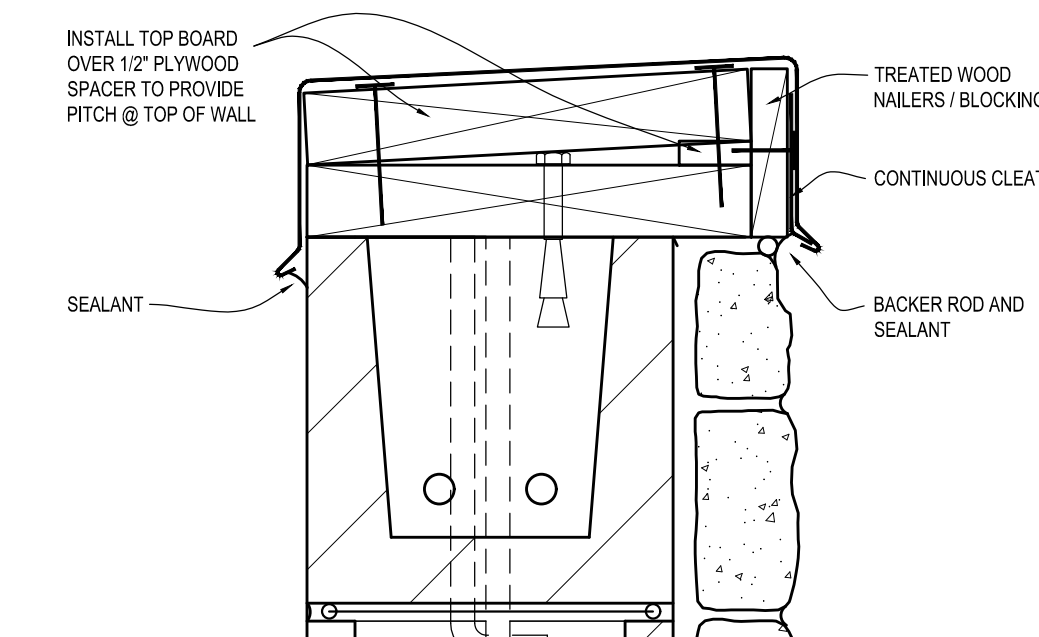

F7 DETAIL
SCALE : 3" = 1'-0"

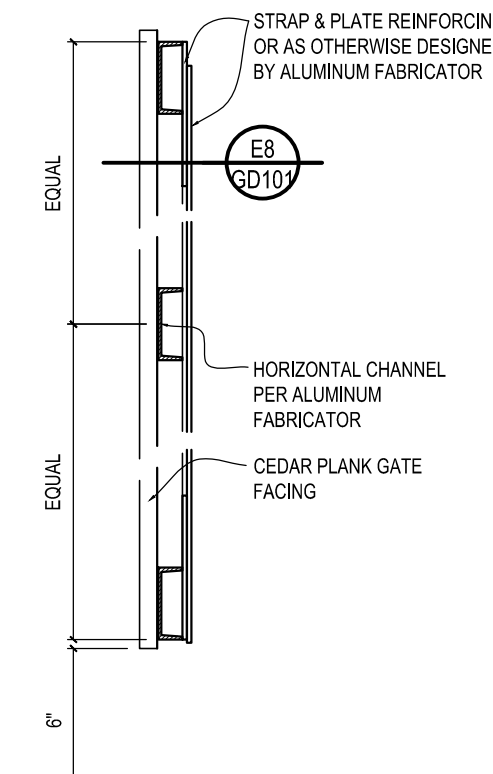


G8 DETAIL
SCALE : 1 1/2" = 1'-0"

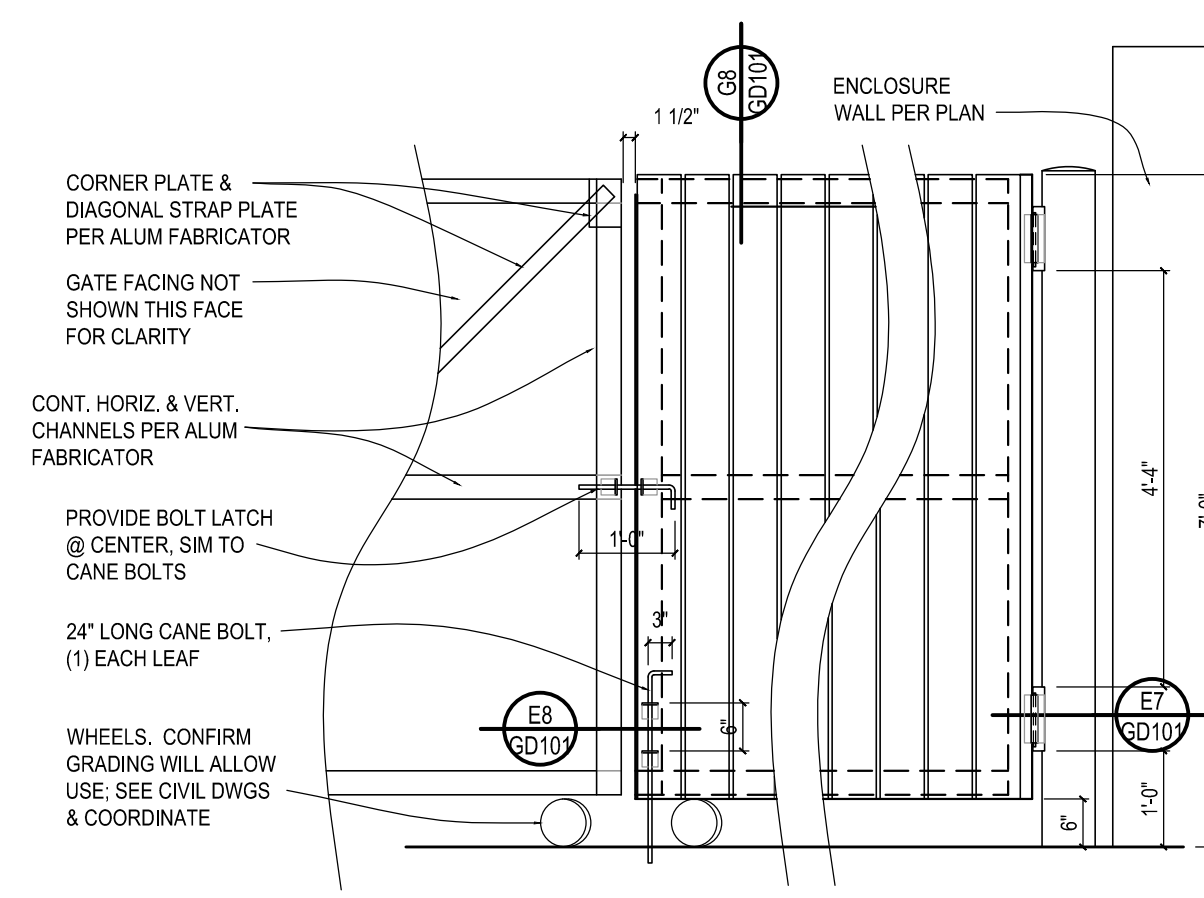

H7 ENCLOSURE GATE ELEV
SCALE : 1/2" = 1'-0"

PRELIMINARY

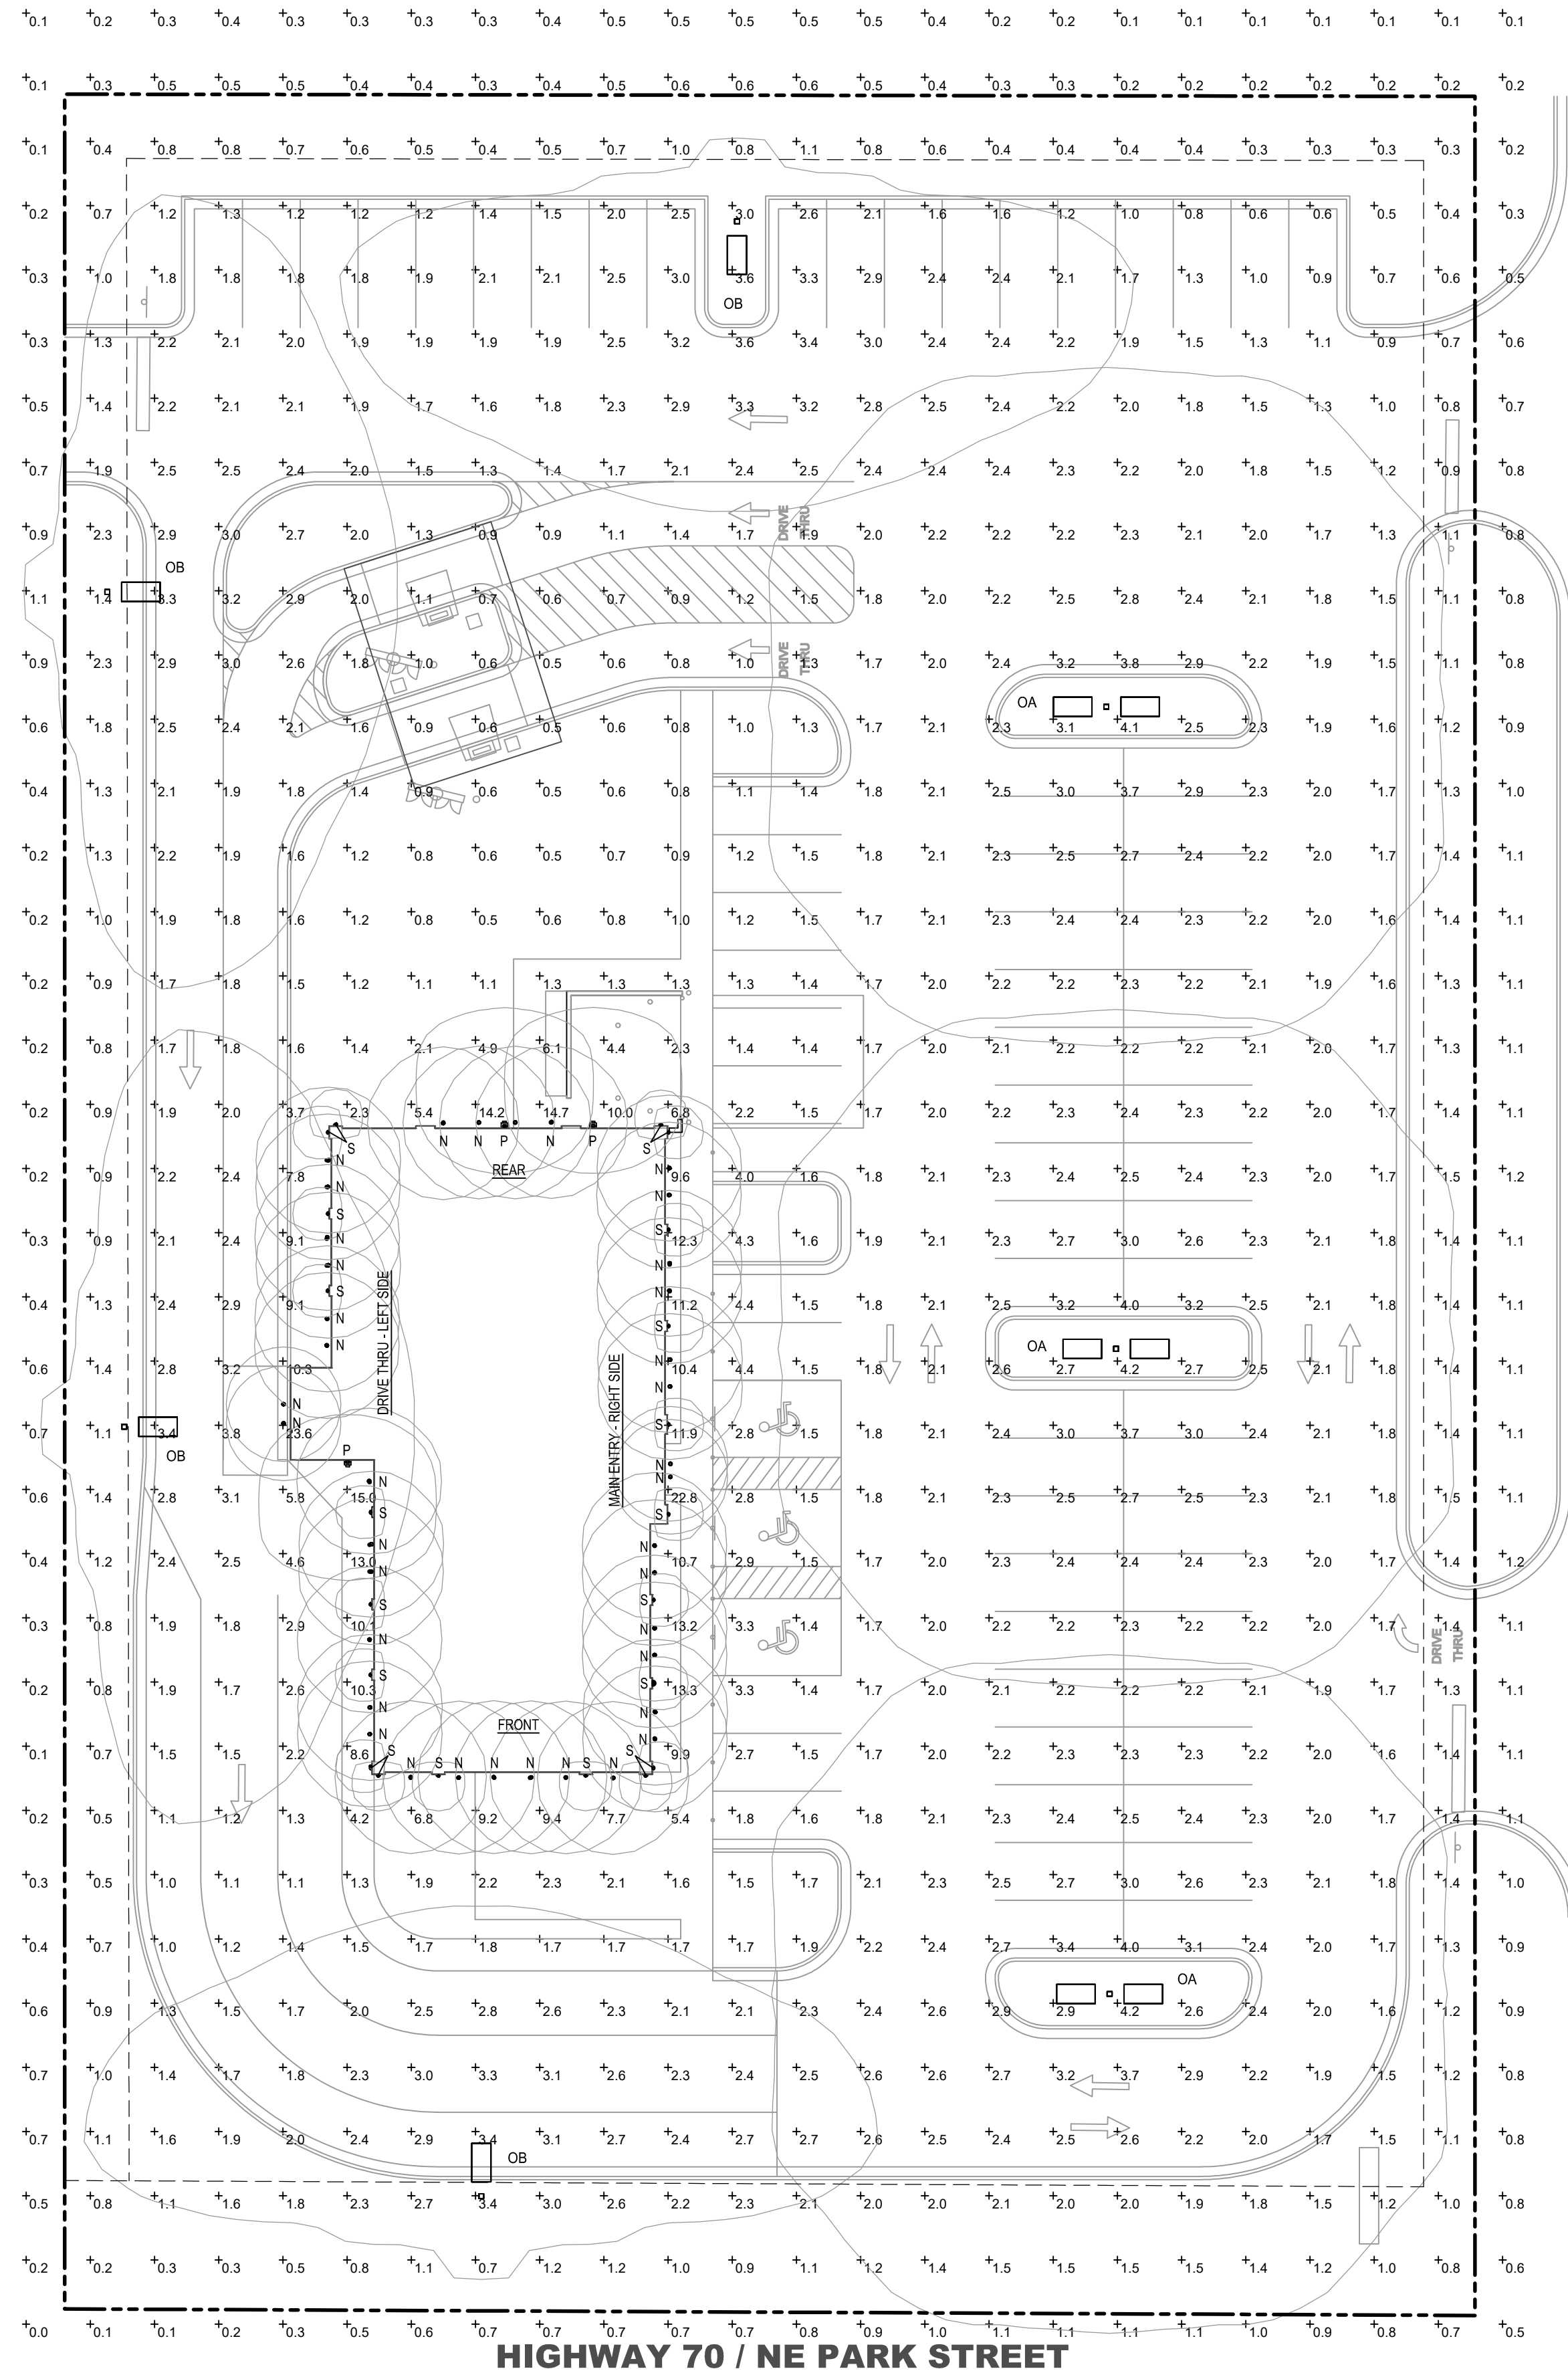

HIGHWAY 70 / NE PARK STREET

F6 SITE PHOTOMETRIC PLAN
SCALE: 1" = 20'-0"

LUMINAIRE SCHEDULE - SITE LIGHTING				
ALL POLES SHALL BE CONCRETE				
SYMBOL	LABEL	CATALOGUE NUMBER	LAMP	WATTS
	OA	(2) DSX1 LED P6 40K TSW MVOLT 25' POLE	LED	326
	OB	DSX1 LED P6 40K T2M MVOLT 25' POLE	LED	163

LUMINAIRE SCHEDULE - BUILDING MOUNT				
SYMBOL	LABEL	CATALOGUE NUMBER	LAMP	WATTS
	N	LDN6 4016 LOGAR LS MVOLT G210 WL LITHONIA	LED	19
	P	SLIM18N RAB LIGHTING	LED	18
	S	OLLWU LED P1 40K 120 DOB LITHONIA	LED	11

LIGHTING STATISTICS		
Average	2.0	fc
Maximum	23.6	fc
Minimum	0.0	fc
Max/Min	N/A	
Average/Min	N/A	

© 2023

NEW CULVER'S RESTAURANT
975 NE Park Street
Okeechobee, FL 34973
County of OKEECHOBEE

SEAL

OWNER:

S & L Properties Okeechobee LLC
2651 Kinking Court
Portage, WI 53901
Jeffrey J. Legel, Realty Manager / Member
608-742-2893

OLLMANN ASSOCIATES ARCHITECTS, P.C.

200 South State Street
Belvidere, Illinois 61008
815-544-7790 Phone
© OAA All rights reserved, any copying, transmittal or
disclosure subject to OAA written approval.

SITE PHOTOMETRIC PLAN

Revision:

Date: 4-27-2023

2023-010

SE
101

PRELIMINARY



FEATURES & SPECIFICATIONS

INTENDED USE

Provides years of maintenance-free illumination for outdoor use in residential & commercial applications. Ideal for applications such as lighting walkways and stairways for safety and security.

CONSTRUCTION

Cast aluminum housing with corrosion-resistant paint in either dark bronze or white finish. ADA compliant.

OPTICS

4000K CCT LED.

Polycarbonate lens protects the LED from moisture, dirt and other contaminants.

LUMEN MAINTENANCE: The LED will deliver 70% of its initial lumens at 50,000 hour average LED life. See Lighting Facts label on page 2 for performance details.

ELECTRICAL

MVOLT driver operates on any line voltage from 120-277V

Operating temperature -30°C to 40°C.

1KV surge protection standard.

INSTALLATION

Surface mounts to universal junction box (provided by others).

LISTINGS

UL Listed to U.S. and Canadian safety standards for wet locations.

Tested in accordance with IESNA LM-79 and LM-80 standards.

WARRANTY — 5-year limited warranty. Complete warranty terms located at www.acuitybrands.com/CustomerResources/terms_and_conditions.aspx

Actual performance may differ as a result of end-user environment and application.

All values are design or typical values, measured under laboratory conditions at 25 °C.

Note: Specifications subject to change without notice.


Catalog Number	
Notes	
Type	

OLLWD & OLLWU

LED WALL CYLINDER LIGHT



Specifications
All dimensions are inches (centimeters)

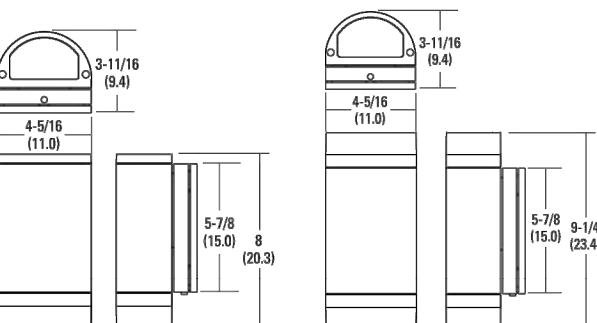

ORDERING INFORMATION For shortest lead times, configure products using **bolded options**.

Example: OLLWD LED P1 40K MVOLT DDB

Series	Performance Package	Color temperature (CCT)	Voltage	Finish
OLLWD LED Downlight	P1	40K 4000K	MVOLT 120V-277V	DDB Dark bronze
OLLWU LED Up & downlight			120 120V ¹	WH White

Notes
1 Only available with OLLWU and in DDB.

DECORATIVE INDOOR & OUTDOOR

OLLWD-OLLWU



FEATURES & SPECIFICATIONS

INTENDED USE — Typical applications include corridors, lobbies, conference rooms and private offices.

CONSTRUCTION — Galvanized steel mounting/plaster frame; galvanized steel junction box with bottom-hinged covers and spring latches. Reflectors are retained by tension springs. Vertically adjustable mounting brackets with commercial bar hangers provide 3-3/4" total adjustment. Two combination 1/2"-3/4" and four 1/2" knockouts for straight-through conduit runs. Capacity: 8 (4 in, 4 out). No. 12 AWG conductors, rated for 90°C.

Accommodates 1/2"-2" joint spacing.

Passive cooling thermal management for 25°C standard; high ambient (40°C) option available. Light engine and drivers are accessible from above or below ceiling.

Max ceiling thickness 1-1/2".

OPTICS — LEDs are binned to a 3-step SDCM; 80 CRI minimum.

LED light source concealed with diffusing optical lens.

General illumination lighting with 1.0 S/MH and 55° cutoff to source and source image.

Self-flanged anodized reflectors in specular, semi-specular, or matte diffuse finishes. Also available in white and black painted reflectors.

ELECTRICAL — Multi-volt (120-277V, 50/60Hz) eLED 0-10V dimming drivers mounted to junction box, 10% or 1% minimum dimming level available.

0-10V dimming fixture requires two (2) additional low-voltage wires to be pulled.

70% lumen maintenance at 50,000 hours.

LISTINGS — Certified to US and Canadian safety standards. Dump location standard (wet location, covered ceiling optional). ENERGY STAR® certified product.

WARRANTY — 5-year limited warranty. Complete warranty terms located at www.acuitybrands.com/CustomerResources/terms_and_conditions.aspx

Note: Actual performance may differ as a result of end-user environment and application.

All values are design or typical values, measured under laboratory conditions at 25 °C.

Specifications subject to change without notice.

A+ Capable options indicated by this color background.

ORDERING INFORMATION Lead times will vary depending on options selected. Consult with your sales representative. Example: LDN6 35/15 L06AR LSS MVOLT EZ10

LDN6	40/15	L06AR	LS	MVOLT
Series	Color temperature	Lumens ¹	Aperture/Trim Color	Finish
LDN6, 6" round	27/ 2700K 30/ 3000K 35/ 3500K 40/ 4000K 50/ 5000K	10 500 lumens 15 1500 lumens 20 2000 lumens 25 2500 lumens 30 3000 lumens 40 4000 lumens 50 5000 lumens	L06 Downlight LW6 Wallwash	AB Clear BR Black
			WR White	LSS Semi-specular LD Matte diffuse LS Specular
				MVOLT Multi-volt 120 120V 277 277V

EZ10	WL
Driver	Options
EZ10 0-10V eLED driver with smooth and flicker-free deep dimming performance down to 1%	SP ¹ Single fuse TRW ² White painted flange TRM ³ Black painted flange EL ⁴ Emergency battery pack with integral test switch, CEC compliant ELR ⁵ Emergency battery pack with integral test switch, CEC compliant NPS80EZ ⁶ nLight [®] dimming pack controls 0-10V eLED drivers. NPS80EZER ⁷ nLight [®] dimming pack controls 0-10V eLED drivers. ER controls fixtures on emergency circuit.
EZ1 0-10V eLED driver with smooth and flicker-free deep dimming performance down to 1%	N80 ⁸ HAQ ⁹ nLight [™] Lumen Compensation High ambient option HBL ¹⁰ nLight [™] Location RELC ¹¹ Ready luminaire connectors enable a simple and consistent factory installed option across all ABL luminaire brands. Refer to RRL for complete nomenclature. Available only in RRLA, RRLB, RRLAT, and RRLC125. USPM ¹³ US point of manufacture

Accessories: Order as separate catalog number.
EAC SS3M.375 Compact interruptible emergency AC power system
EAC SS3M.125 Compact interruptible emergency AC power system
GRA68.1Z Oversized trim ring with 8" outside diameter ¹
SCA6 Sloped ceiling adapter. Refer to TECH-SCL for more options.

Notes
1 Overall height varies based on lumen package; refer to dimensional chart on page 3.
2 Not available with finishes.
3 120V only.
4 Available with clear (AB) reflector only.
5 Add "SP" for self-diagnostic option (i.e. EL50)
6 Must specify voltage 120V or 277V.
7 Fixture begins at 80% light level. Must be specified with NPS80EZ or NPS80EZ ER. Only available with EZ10 and EZ1 drivers.
8 Fixture height is 6.5" for all lumen packages with HAQ.

DOWNLIGHTING

LDN6

SLIM18N

RAB Outdoor	
Project:	Type:
Prepared By:	Date:
Driver Info	LED Info
Type: Constant Current	Watts: 18W
120V: 0.18A	Color Temp: 4000K (Neutral)
208V: 0.11A	Color Accuracy: 74 CRI
240V: 0.09A	L70 LifeSpan: 100,000
277V: 0.08A	Lumens: 2,556
Input Watts: 21W	Efficacy: 120 LPW
Efficiency: 85%	

12, 18 and 26 Watt SLIM wallpacks are ultra efficient and deliver impressive light distribution with a compact low-profile design that's super easy to install as a downlight or uplight.

Color: Bronze

Weight: 4.3 lbs

Technical Specifications

Listings

UL Listing:

Suitable for wet locations. Suitable for mounting within 1.2m (4ft) of the ground.

ADA Compliant:

SLIM™ is ADA Compliant

IESNA LM-79 & LM-80 Testing:

RAB LED luminaires and LED components have been tested by an independent laboratory in accordance with IESNA LM-79 and LM-80.

DLC Listed:

This product is on the Design Lights Consortium (DLC) Qualified Products List and is eligible for rebates from DLC Member Utilities.
DLC Product Code: P0000171P

Construction

IP Rating:

Ingress Protection rating of IP66 for dust and water

Cold Weather Starting:

Minimum operating temperature is -40°C (-40°F)

Maximum Ambient Temperature:

Suitable for use at 40°C (104°F)

Housing:

Precision die-cast aluminum housing

Mounting:

Heavy-duty mounting bracket with hinged housing for easy installation

Recommended Mounting Height:

Up to 14 ft.

Lens:

Tempered glass lens

Reflector:

Specular thermoplastic

Gaskets:

High-temperature silicone

Finish:

Formulated for high durability and long-lasting color

Green Technology:

Mercury and UV free. RoHS-compliant components.

LED Characteristics

LED:

Multi-chip, long-life LED

Lifespan:

100,000-hour LED lifespan based on IES LM-80 results and TM-21 calculations

Color Consistency:

3-step MacAdam Ellipse binning to achieve consistent fixture-to-fixture color

Color Stability:

LED color temperature is warranted to shift no more than 200K in CCT over a 5-year period

Color Uniformity:

RAB's range of CCT (Correlated Color Temperature) follows the guidelines for the American National Standard for Specifications for the Chromaticity of Solid State Lighting (SSL) Products, ANSI C78.377-2017.

Other

Patents:

The design of the SLIM™ is protected by patents in U.S. Pat D661,864, and pending patents in Canada, China, Taiwan and Mexico.

HID Replacement Range:

Replaces 100W Metal Halide

Buy American Act Compliance:

RAB values USA manufacturing! Upon request, RAB may be able to manufacture this product to be compliant with the Buy American Act (BAA). Please contact customer service to request a quote for the product to be made BAA compliant.

Optical

BUG Rating:

B1 U0 G0

Electrical

Driver:

Constant Current, Class 2, 100-277V, 50/60 Hz, 4KV surge protection, 120V: 0.18A, 208V: 0.11A, 240V: 0.10A, 277V: 0.08A

THD:

11% at 120V, 21% at 277V

Need help? Tech help line: (888) RAB-1000 Email: custserv@rablighting.com Website: www.rablighting.com


Copyright © 2019 RAB Lighting Inc. All Rights Reserved. Note: Specifications are subject to change at any time without notice

Page 1 of 2



Specifications

EPA: 1.01 ft² (0.09 m²)
Length: 33" (0.84 m)
Width: 13" (0.33 m)
Height: 7-1/2" (0.19 m)
Weight (max): 27 lbs (12.3 kg)

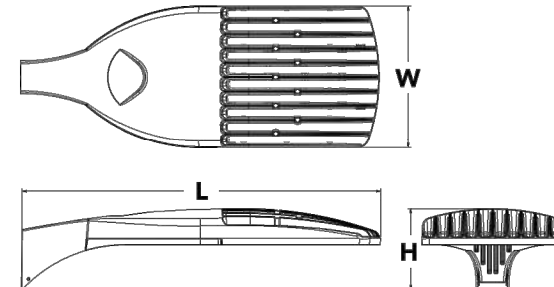

A+ Capable options indicated by this color background.

Ordering Information

EXAMPLE: DSX1 LED P7 40K T3M MVOLT SPA DDBXD


Series	LEDs	Color temperature	Distribution	Voltage	Mounting
DSX1 LED	Forward optics P1 P4 P7 P2 P5 P8 P3 P6 P9 Rotated optics P10 ¹ P12 ² P11 ³ P13 ⁴	30K 3000 K 40K 4000 K 50K 5000 K AMPC Amber phosphor converted ⁵	T15 Type I short T25 Type II short T2M Type II medium T35 Type II short T3M Type II medium T4M Type IV medium TF1M Forward throw medium TSV5 Type V very short	T35 Type V short TSM Type V medium TSW Type V wide BLC Backlight corner ⁶ LCCO Left corner cutoff ⁷ RCO Right corner cutoff ⁸	MVOLT ^{1,5} 120 ¹ 208 ^{1,5} 240 ^{1,5} 277 ¹ 347 ^{1,5,7} 480 ^{1,5,7}

Shipped included
SPA Square pole mounting
RPA Round pole mounting
WBA Wall bracket
SPUBA Square pole universal mounting adaptor⁴
RPUUBA Round pole universal mounting adaptor⁴
Shipped separately
KMA8 DDBXD U Mast arm mounting bracket adaptor (specify finish)⁹

Control options	Finish options	Finish options
Shipped installed DLN102 nLight AIR generation 2 enabled ¹⁰ PER1 NEMA hand lock receptacle only (controls ordered separately) ¹¹ PER5 Five-wire receptacle only (controls ordered separately) ^{11,12} PER7 Seven-wire receptacle only (controls ordered separately) ^{11,12} DMG 0-10V dimming extend out back of housing for external control (leads exit fixture) DS Dual switching ¹³ PB Bi-level motion/ambient sensor, 0-15' mounting height, ambient sensor enabled at 5K ^{13,14} PR Bi-level motion/ambient sensor, 15-30' mounting height, ambient sensor enabled at 5K ^{13,14} PRIN Bi-level motion/ambient sensor ¹⁵ PRIFCV Bi-level motion/ambient sensor, 0-15' mounting height, ambient sensor enabled at 1K ^{13,14}	PRIFCVY Bi-level motion/ambient sensor, 15-30' mounting height, ambient sensor enabled at 1K ^{13,14} BL30 Bi-level switched dimming, 30% 1/4" 347V ¹ BL50 Bi-level switched dimming, 50% 1/4" 347V ¹ PIM703 Part right, dim 5 hrs ^{1,9} PIM703 Part right, dim 6 hrs ^{1,9} PIM703 Part right, dim 7 hrs ^{1,9} FAO Field adjustable output ⁸	Shipped installed HS House-side shield ¹⁶ SF Single-fuse (120, 277, 347V) ¹ DF Double-fuse (208, 240, 480V) ¹ L90 Left rotated optics ¹ R90 Right rotated optics ¹ Shipped separately BS Bird spikes ¹⁷ EGS External glare shield ¹⁸

LITHONIA LIGHTING One Lithonia Way • Cary, Georgia 30012 • Phone: 800.279.8041 • www.lithonia.com
© 2011-2018 Acuity Brands Lighting, Inc. All rights reserved.

DSX1 LED
Rev. 07/2018
Page 1 of 7

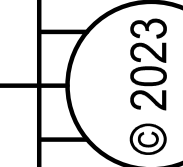


NEW CULVER'S RESTAURANT
975 NE Park Street
Okeechobee, FL 34973
County of OKEECHOBEE

SEAL

OWNER:
S & L Properties Okeechobee LLC
2651 Kyring Court
Portage, WI 53901
Jeffrey J. Legal, Realty Manager / Member
608-742-2893

OLLMANN ASSOCIATES ARCHITECTS, P.C.
200 South State Street
Belvidere, Illinois 61008
815-544-7790 Phone
© OAA All rights reserved; any copying, transmission or
disclosure subject to OAA written approval.

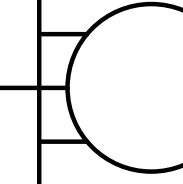

SITE FIXTURE DETAILS

Revision:

Date: 1-27-2023

2023-010

